
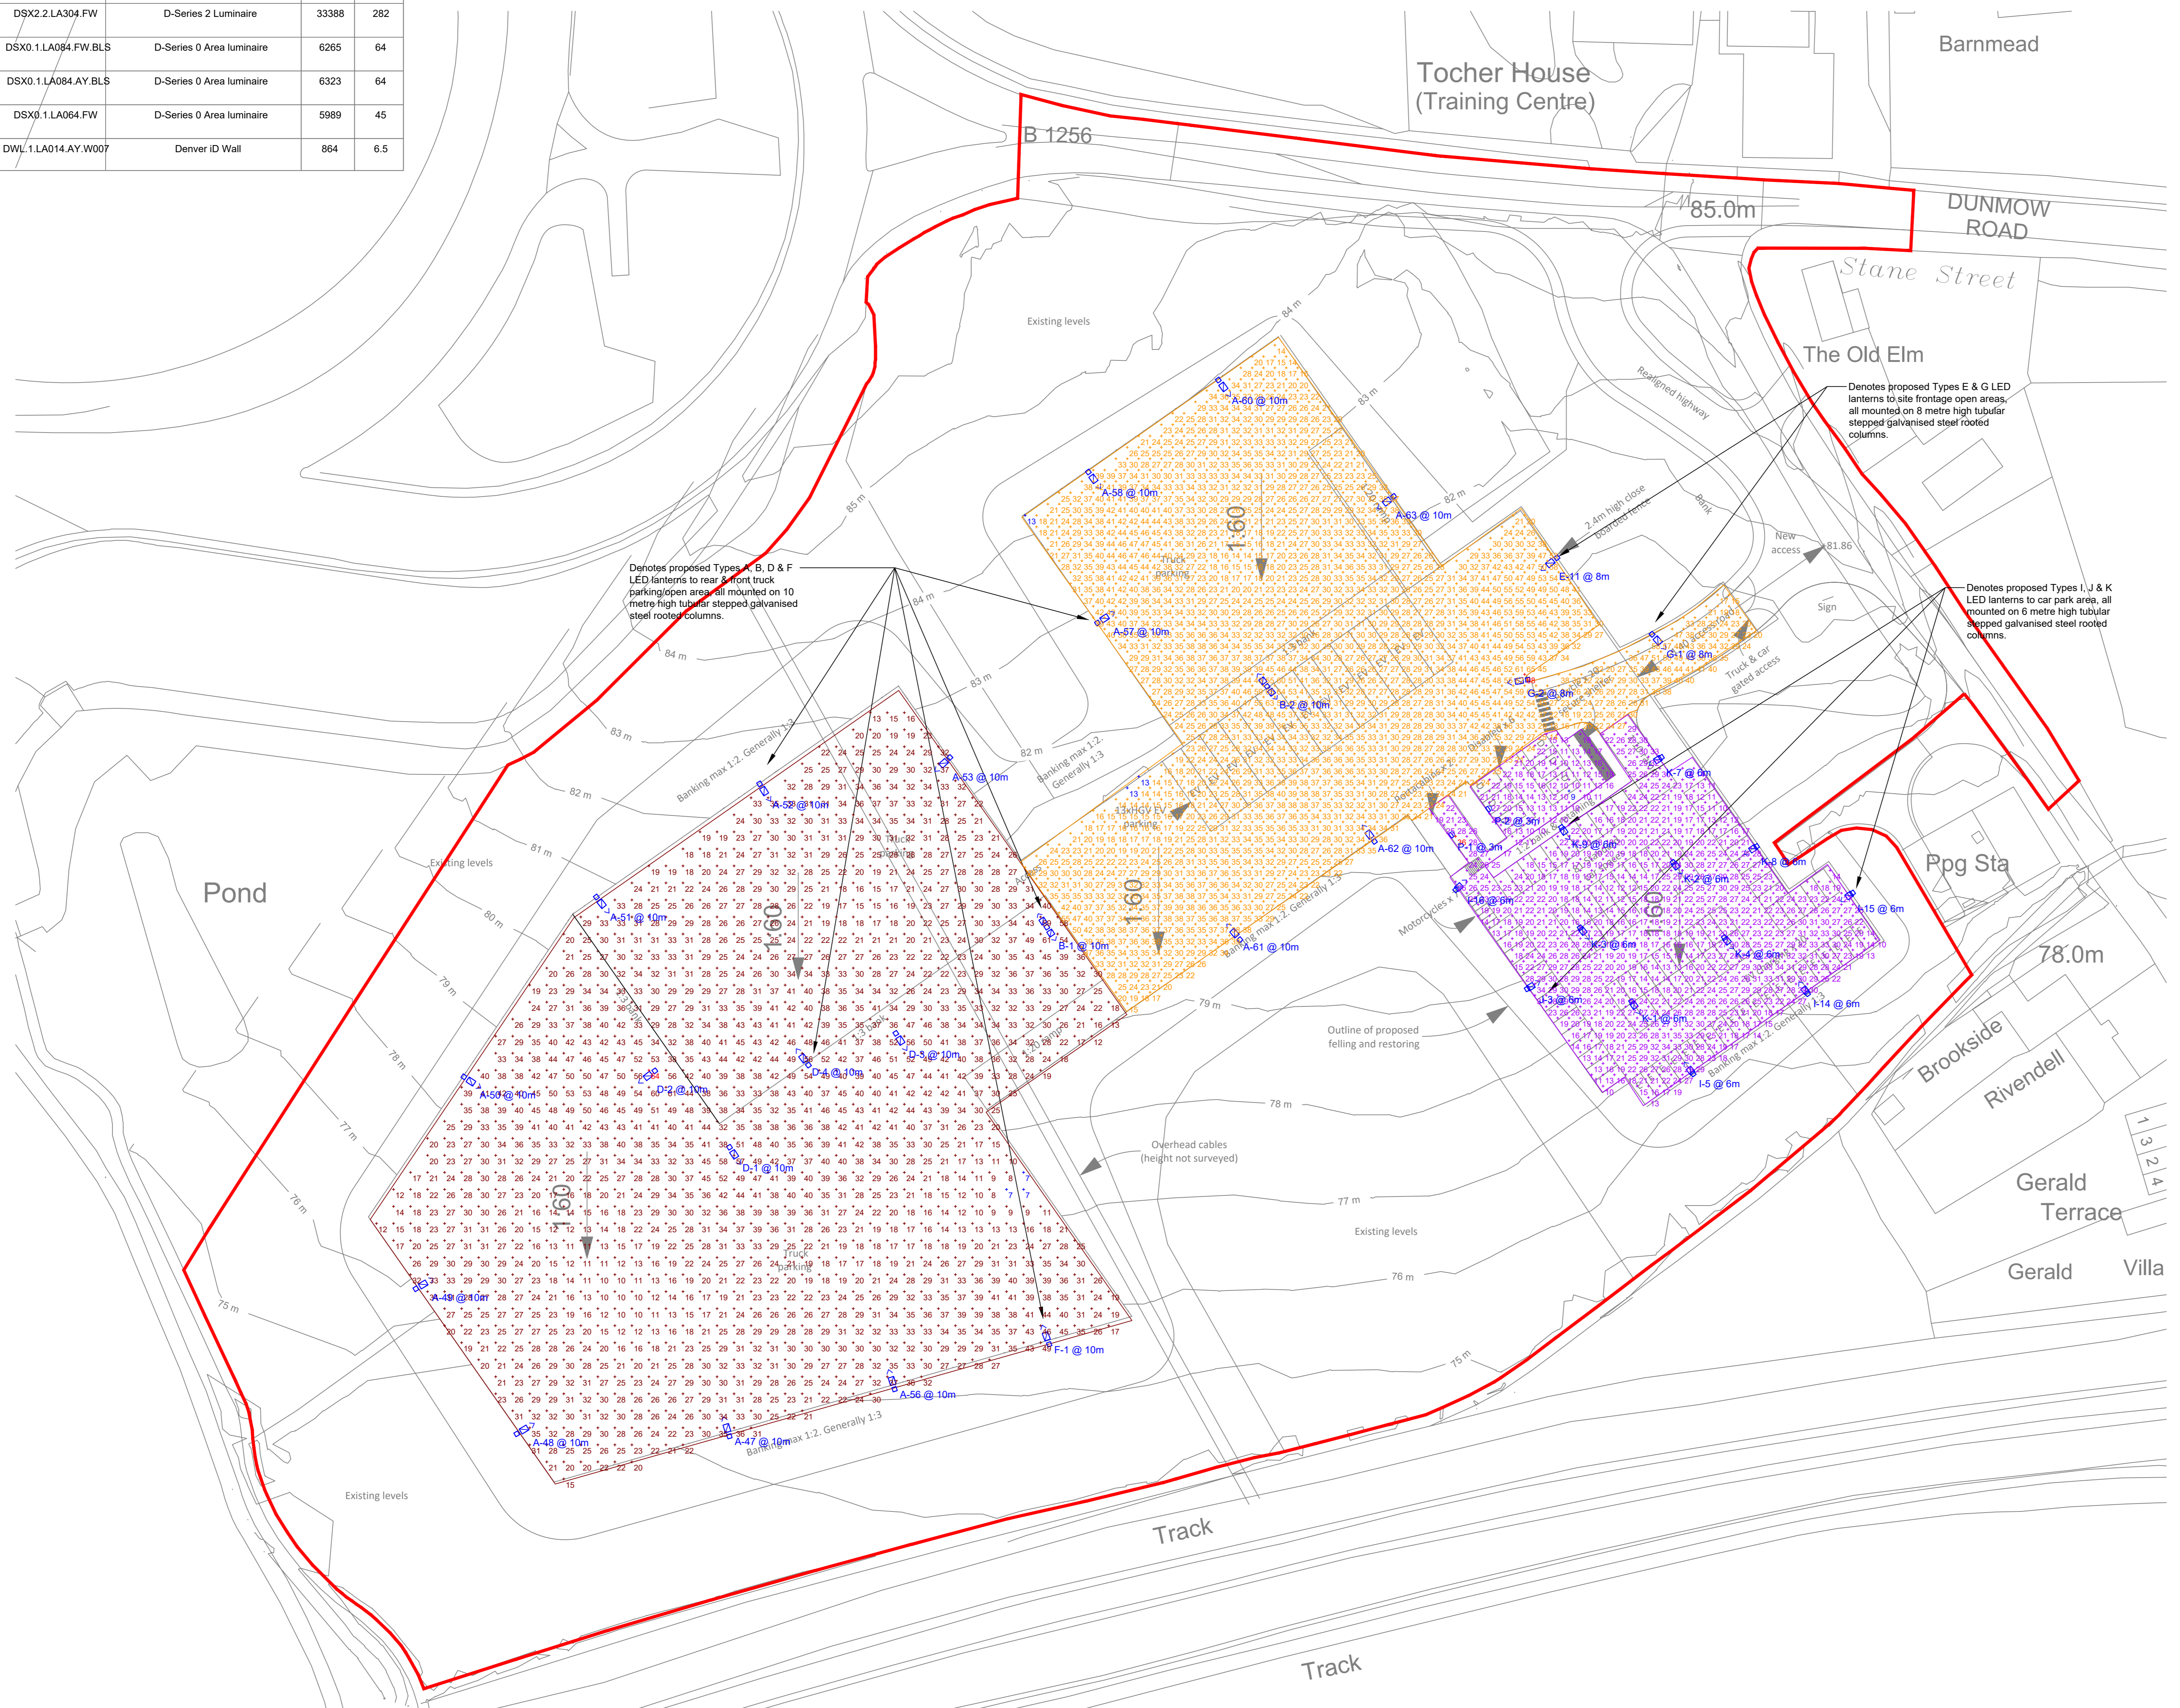



NOTE:-
ELECTRICAL CONTRACTOR TO CONFIRM ALL LIGHTING LAYOUTS COMPLY WITH LIGHTING LEVELS AND UNIFORMITY STATED WITHIN SPECIFICATION.
LUMINAIRE SHOWN FOR INFORMATION ONLY.

| Symbol | Label | Quantity | Catalog Number | Description | Lumens Per Lamp | Wattage |
|--------|-------|---------------------|---|-------------|-----------------|---------|
| A | 14 | DSX2.2.LA304.FW.BLS | D-Series 2 Luminaire with Back Light Shield | 26068 | 282 | |
| B | 2 | DSX1.2.LA304.AY | D-Series 1 Luminaire | 29463 | 572 | |
| D | 4 | DSX2.2.LA364.FW | D-Series 2 Luminaire | 40787 | 328 | |
| E | 1 | DSX2.2.LA304.FW.BLS | D-Series 2 Luminaire with Back Light Shield | 26068 | 282 | |
| F | 1 | DSX2.2.LA364.FW.BLS | D-Series 2 Luminaire with Back Light Shield | 31845 | 328 | |
| G | 2 | DSX2.2.LA304.FW | D-Series 2 Luminaire | 33388 | 282 | |
| I | 4 | DSX0.1.LA084.FW.BLS | D-Series 0 Area luminaire | 6265 | 64 | |
| J | 1 | DSX0.1.LA084.AY.BLS | D-Series 0 Area luminaire | 6323 | 64 | |
| K | 7 | DSX0.1.LA064.FW | D-Series 0 Area luminaire | 5989 | 45 | |
| P | 2 | DWL.1.LA014.AY.W007 | Denver ID Wall | 864 | 6.5 | |


| Statistics | | | | |
|-------------|--------|--------|-------|---------|
| Description | Symbol | Avg | Min | Min/Avg |
| Area 1 | + | 29 lux | 7 lux | 0.24 |
| Area 2 | + | 32 lux | 3 lux | 0.41 |
| Car Park | + | 21 lux | 9 lux | 0.43 |

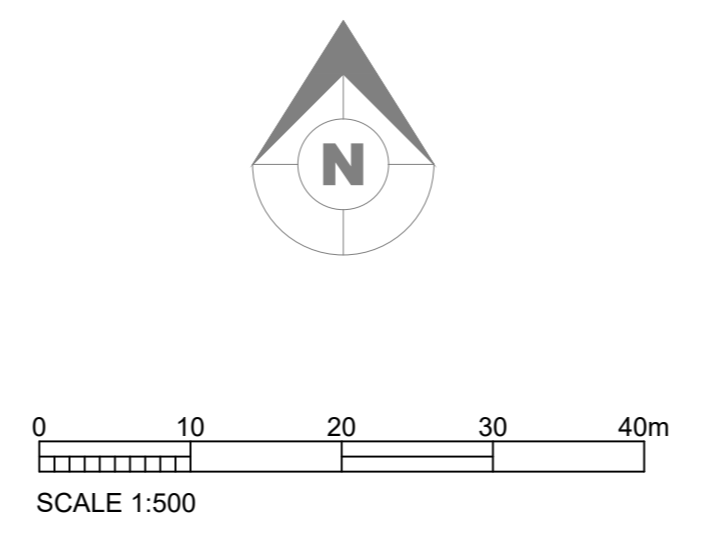

Catalog Number: Label:
DWL.1.LA014.AY.W007 P
All lanterns to be delivered having factory silver paint finish

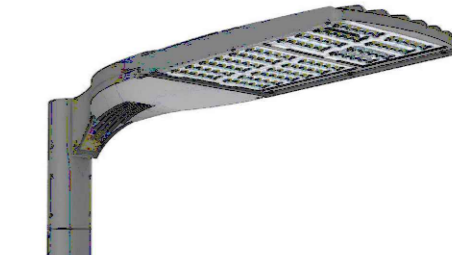

Catalog Number: Label:
DSX2.2.LA304.FW.BLS A
DSX2.2.LA364.FW D
Twin Version of 'A' E
DSX2.2.LA364.FW.BLS F
DSX2.2.LA304.FW G
All lanterns to be delivered having factory silver paint finish

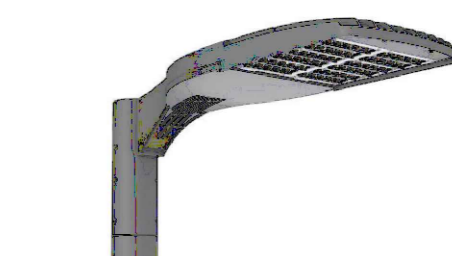

Catalog Number: Label:
DSX1.2.LA304.AY B
(Except Twin Version)
All lanterns to be delivered having factory silver paint finish



Catalog Number: Label:
DSX0.1.LA084.FW.BLS I
DSX0.1.LA084.AY.BLS J
DSX0.1.LA064.FW K
Twin version of 'K' L
All lanterns to be delivered having factory silver paint finish

- KEY:**
- 2.4m high closeboarded sound retardant fence
 - 81 x Standard car spaces
 - 20 x EV car charging spaces
 - 6 x Disabled car parking
 - 107 x Total car spaces
 - 20 x Cycle spaces (Sheffield stands)
 - 13 x EV HGV charging spaces

Illustrations of On-Plot External Lighting Luminaires.

The copyright of this document is vested solely in Kelly Taylor & Associates. Reproduction of this document, in whole or in part, is prohibited other than with the express permission of the above company.

This drawing to be read in conjunction with all relevant architects, consultants, sub-contractors and specialist drawings, and should not be scaled from in any way.

| Revisions | | | | |
|-----------|-----|----------|---|-----|
| Rev. | By | Date | Description | CHK |
| A | RJH | 27.04.21 | Schema illumination levels to the various external areas amended so in line with industry standards/issue guidelines. Column heights reduced to car park & front of development site. | MJP |
| B | CC | 28.01.21 | Updated to suit the latest site plan. | MJP |

Client: **FKY Ltd.**

Architect: **PRC Architects**

Project Address: **Tilekiln Green**

Drawing Title: **External Lighting Lux Level Plot**

KTA
KELLY TAYLOR & ASSOCIATES
ENGINEERING & ENVIRONMENTAL CONSULTANTS
1 ASHLEIGH WAY, LANGAGE BUSINESS PARK,
PLYMOUTH, DEVON, PL7 5JX.
TEL: +44(0)1752 332890 FAX: +44(0)1752 344282
E-MAIL: general@kellytaylor.net

PLANNING

| | | |
|--------------|------------|---------------|
| Drawn by | Checked by | Authorised by |
| RJH | MJP | MJP |
| Scale | Size | Date |
| 1:500 | A0 | Apr'21 |
| Drawing no. | | Rev. |
| 10398-EXT-01 | | B |