

Levels Legend:

29.24	Existing Surveyed Ground Level
FFL 67.950	Proposed Finished Floor Level (FFL)
(Green line)	Minor Road Contours (20mm Vertical Spacing)
(Red line)	Major Road Contours (100mm Vertical Spacing)
(Red line)	Site Boundary




CIVIL / STRUCTURAL DESIGN RISK MANAGEMENT

Abnormal or unusual residual risks associated with the design outcomes shown on this drawing are:-

RSK LDE LTD has followed its Design Risk Management process for Hazard Elimination and Risk reduction in developing the designs shown on this drawing. Abnormal or unusual residual risks may be shown above where it is considered that such risk may not normally be expected by competent persons engaged on work of this nature or type.

Notes:

- This drawing is to be read in conjunction with all relevant Architects and Engineers drawings and specifications.
- All levels quoted are in metres A.O.D.
- All Finished Floor Levels stated are indicative and will be subject to detailed review as part of the audit process for Building Regulation Part M compliance. In this respect the levels shown may deviate by +/- 200mm to ensure level entry requirements access for disabled can be maintained.
- For the Site Drainage Layout refer to Drawing No 0022 - 0024
- All road gullies shall be located away from proposed entrances to houses.
- Kerb upstands to footway adjacent to road pavements to be typically 125mm except on raised tabled and shared access paved area where it will be reduced to 25mm.

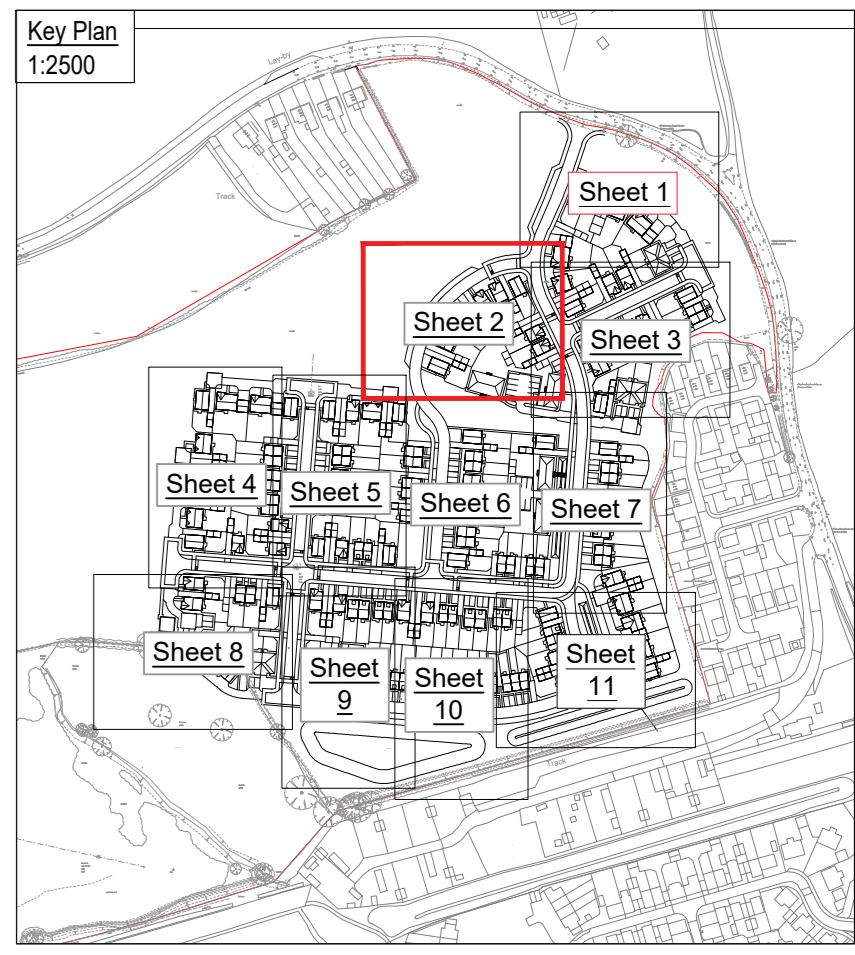

PO3	07.06.2023	Amended to latest architects layout.	LN	GT	GT
PO2	13.07.2023	Amended to latest architects layout.	LN	GT	GT
PO1	05.07.2023	First Issue	LN	AF	GT
Rev.	Date	Amendment	Drawn	Chk.	Appd.



18 Fingernose Road
Hornsea, East Sussex
BN26 9JY
United Kingdom

Tel: +44 (0) 1442 437500
Fax: +44 (0) 1442 437550
Email: info@lde.co.uk



Client: **dandara**

Project Title: **MOOR FIELDS LITTLE DUNMOW**

Status: **PLANNING**

Drawing Title: **SITE LEVELS SHEET 2 OF 11**

Drawn	Date	Checked	Date	Approved	Date
LN	03.06.2023	AF	04.07.2023	GT	05.07.2023

Scale	Orig Size	Dimensions
1:100	A0	Metres

Project No:	Drawing File
134390	134390-RSK-ZZ-DR-C-008-015-Site Levels.dwg

Drawing No:	Rev.
134390	P03

Project	Org	Vol/Iss	Rev/Iss	Type	Rev	Draw No.
134390	RSK	ZZ	DR	C	0007	P03

Scale 1:100

