

**Legend**

- Existing ditch
- Culvert (See annotation)
- 300mm Solid Pipe
- 225mm Solid Pipe
- 150mm Solid Pipe
- 100mm Solid
- 100mm Perforated Pipe (Greens & Tees)
- 100mm Perforated Pipe (Bunkers)
- 100mm Perforated Pipe (Turfgrass)
- Subsurface sleeve 100mm
- Subsurface sleeve 300mm
- Headwall 100mm
- Headwall 300mm
- Rodling Eye (in Valve Box)
- Soakaway

**GENERAL NOTES**

01.

**REVISIONS**

REV	DATE	DESCRIPTION	REV BY	CHK BY

**KEY PLAN**

**CONSULTANT**



**LEAD CONSULTANT**

**CLIENT**



**ISSUED FOR**

**PROJECT**

**DRAWING TITLE**  
Proposed Golf Course Drainage

Drawn	JH	Checked	AC	Approved	RH
Date	20/11/2020	Sheet Size	A1	Scale	1:2500 @A1
Drawing No.	G982 NC 710 PROPOSED GOLF COURSE DRAINAGE			Rev.	

CAD File No. G982 NC 710 PROPOSED GOLF COURSE DRAINAGE  
 Consultant Project No. G982 NC 710 PROPOSED GOLF COURSE DRAINAGE  
 This drawing, the designs and details shown are the copyright of International Design Group and shall not be copied or reproduced in any form without their written consent.  
 © INTERNATIONAL DESIGN GROUP



Legend	
	Existing ditch
	Culvert (See annotation)
	300mm Solid Pipe
	225mm Solid Pipe
	150mm Solid Pipe
	100mm Perforated Pipe (Greens & Tees)
	100mm Perforated Pipe (Bunkers)
	100mm Perforated Pipe (Turfgrass)
	100mm Solid
	Subsurface sleeve 100mm
	Subsurface sleeve 300mm
	Headwall 100mm
	Headwall 300mm
	Rodding Eye (in Valve Box)
	Soakaway


GENERAL NOTES

01.

REVISIONS

REV	DATE	DESCRIPTION	REV BY	CHK BY

KEY PLAN

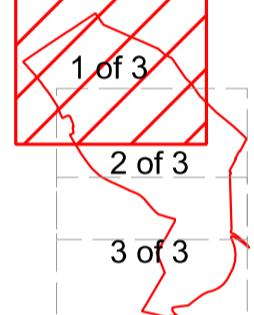

CONSULTANT



LEAD CONSULTANT

CLIENT



ISSUED FOR


PROJECT

DRAWING TITLE


Proposed Golf Course Drainage Plan 1 of 3

Drawn	JH	Checked	AC	Approved	RH
Date	30/07/2020	Sheet Size	A1	Scale	1:1000 @A1
Drawing No.	G982 NC 710-1 PROPOSED GOLF COURSE DRAINAGE PLAN 1 OF 3			Rev.	

CAD File No. G982 NC 710-1 PROPOSED GOLF COURSE DRAINAGE PLAN 1 OF 3  
 Consultant Project No. G982 NC 710-1 PROPOSED GOLF COURSE DRAINAGE PLAN  
 This drawing, the designs and details shown are the copyright of International Design Group and shall not be copied or reproduced in any form without their written consent.  
 © INTERNATIONAL DESIGN GROUP

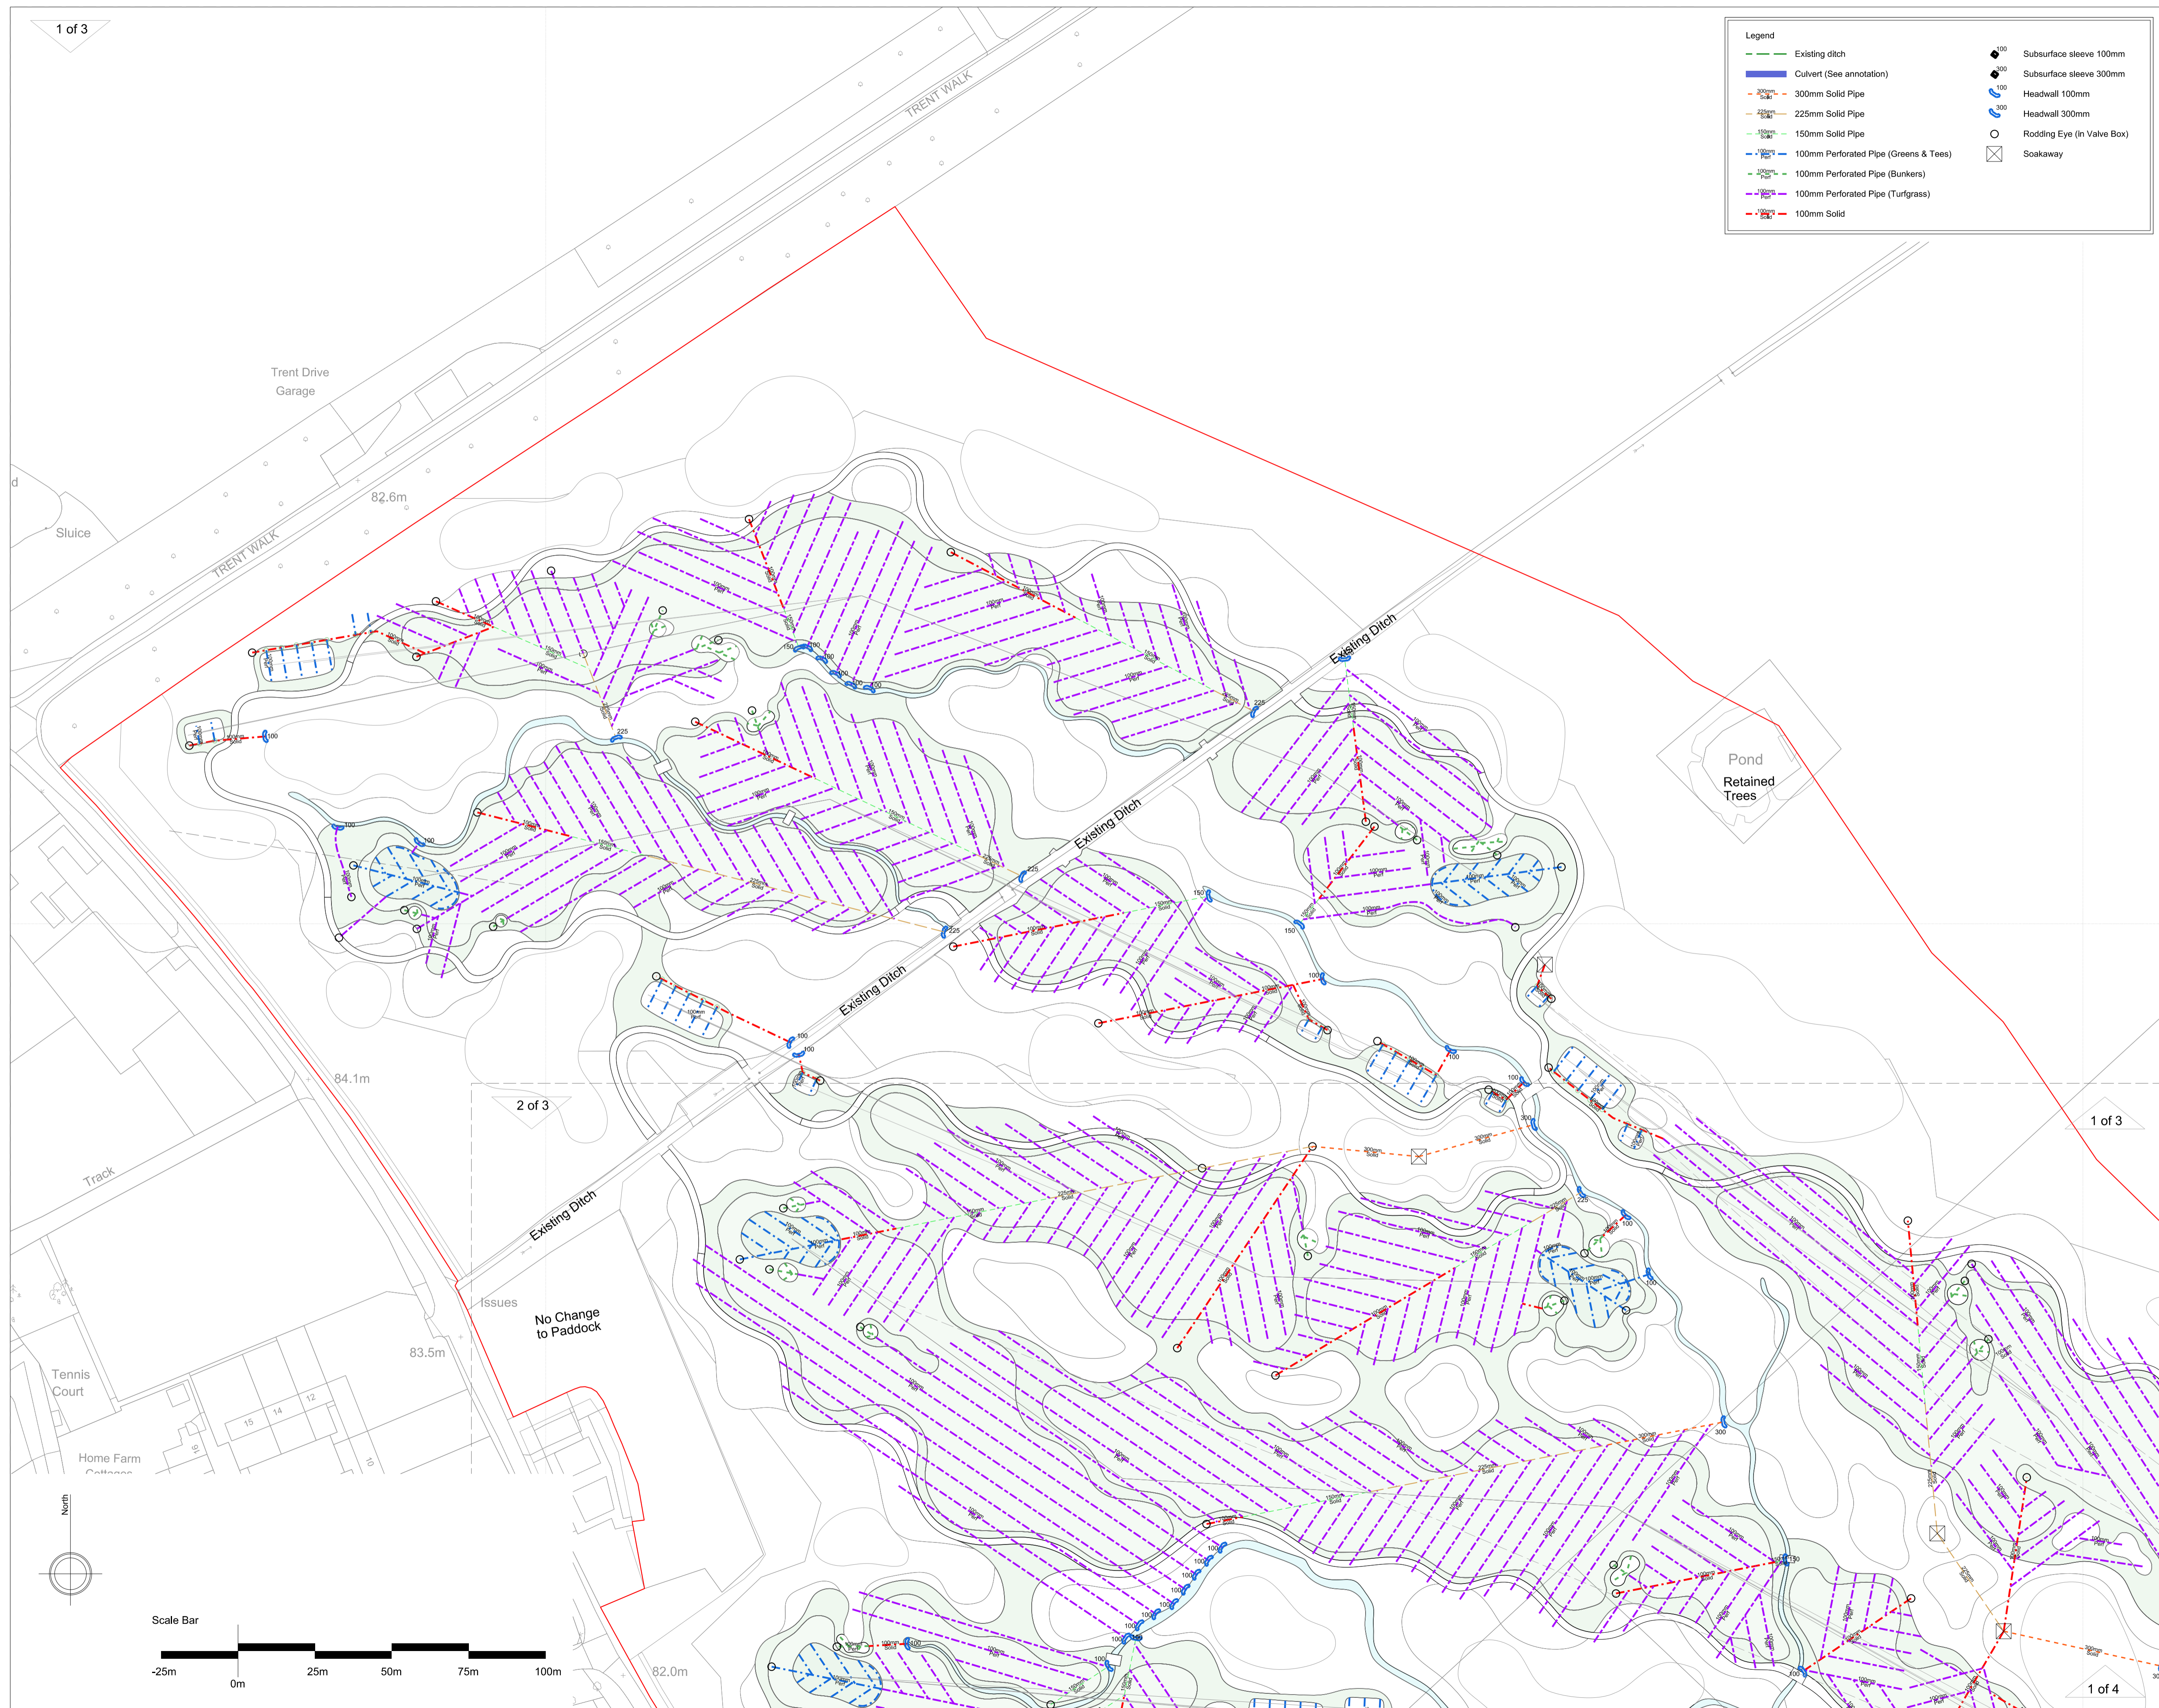



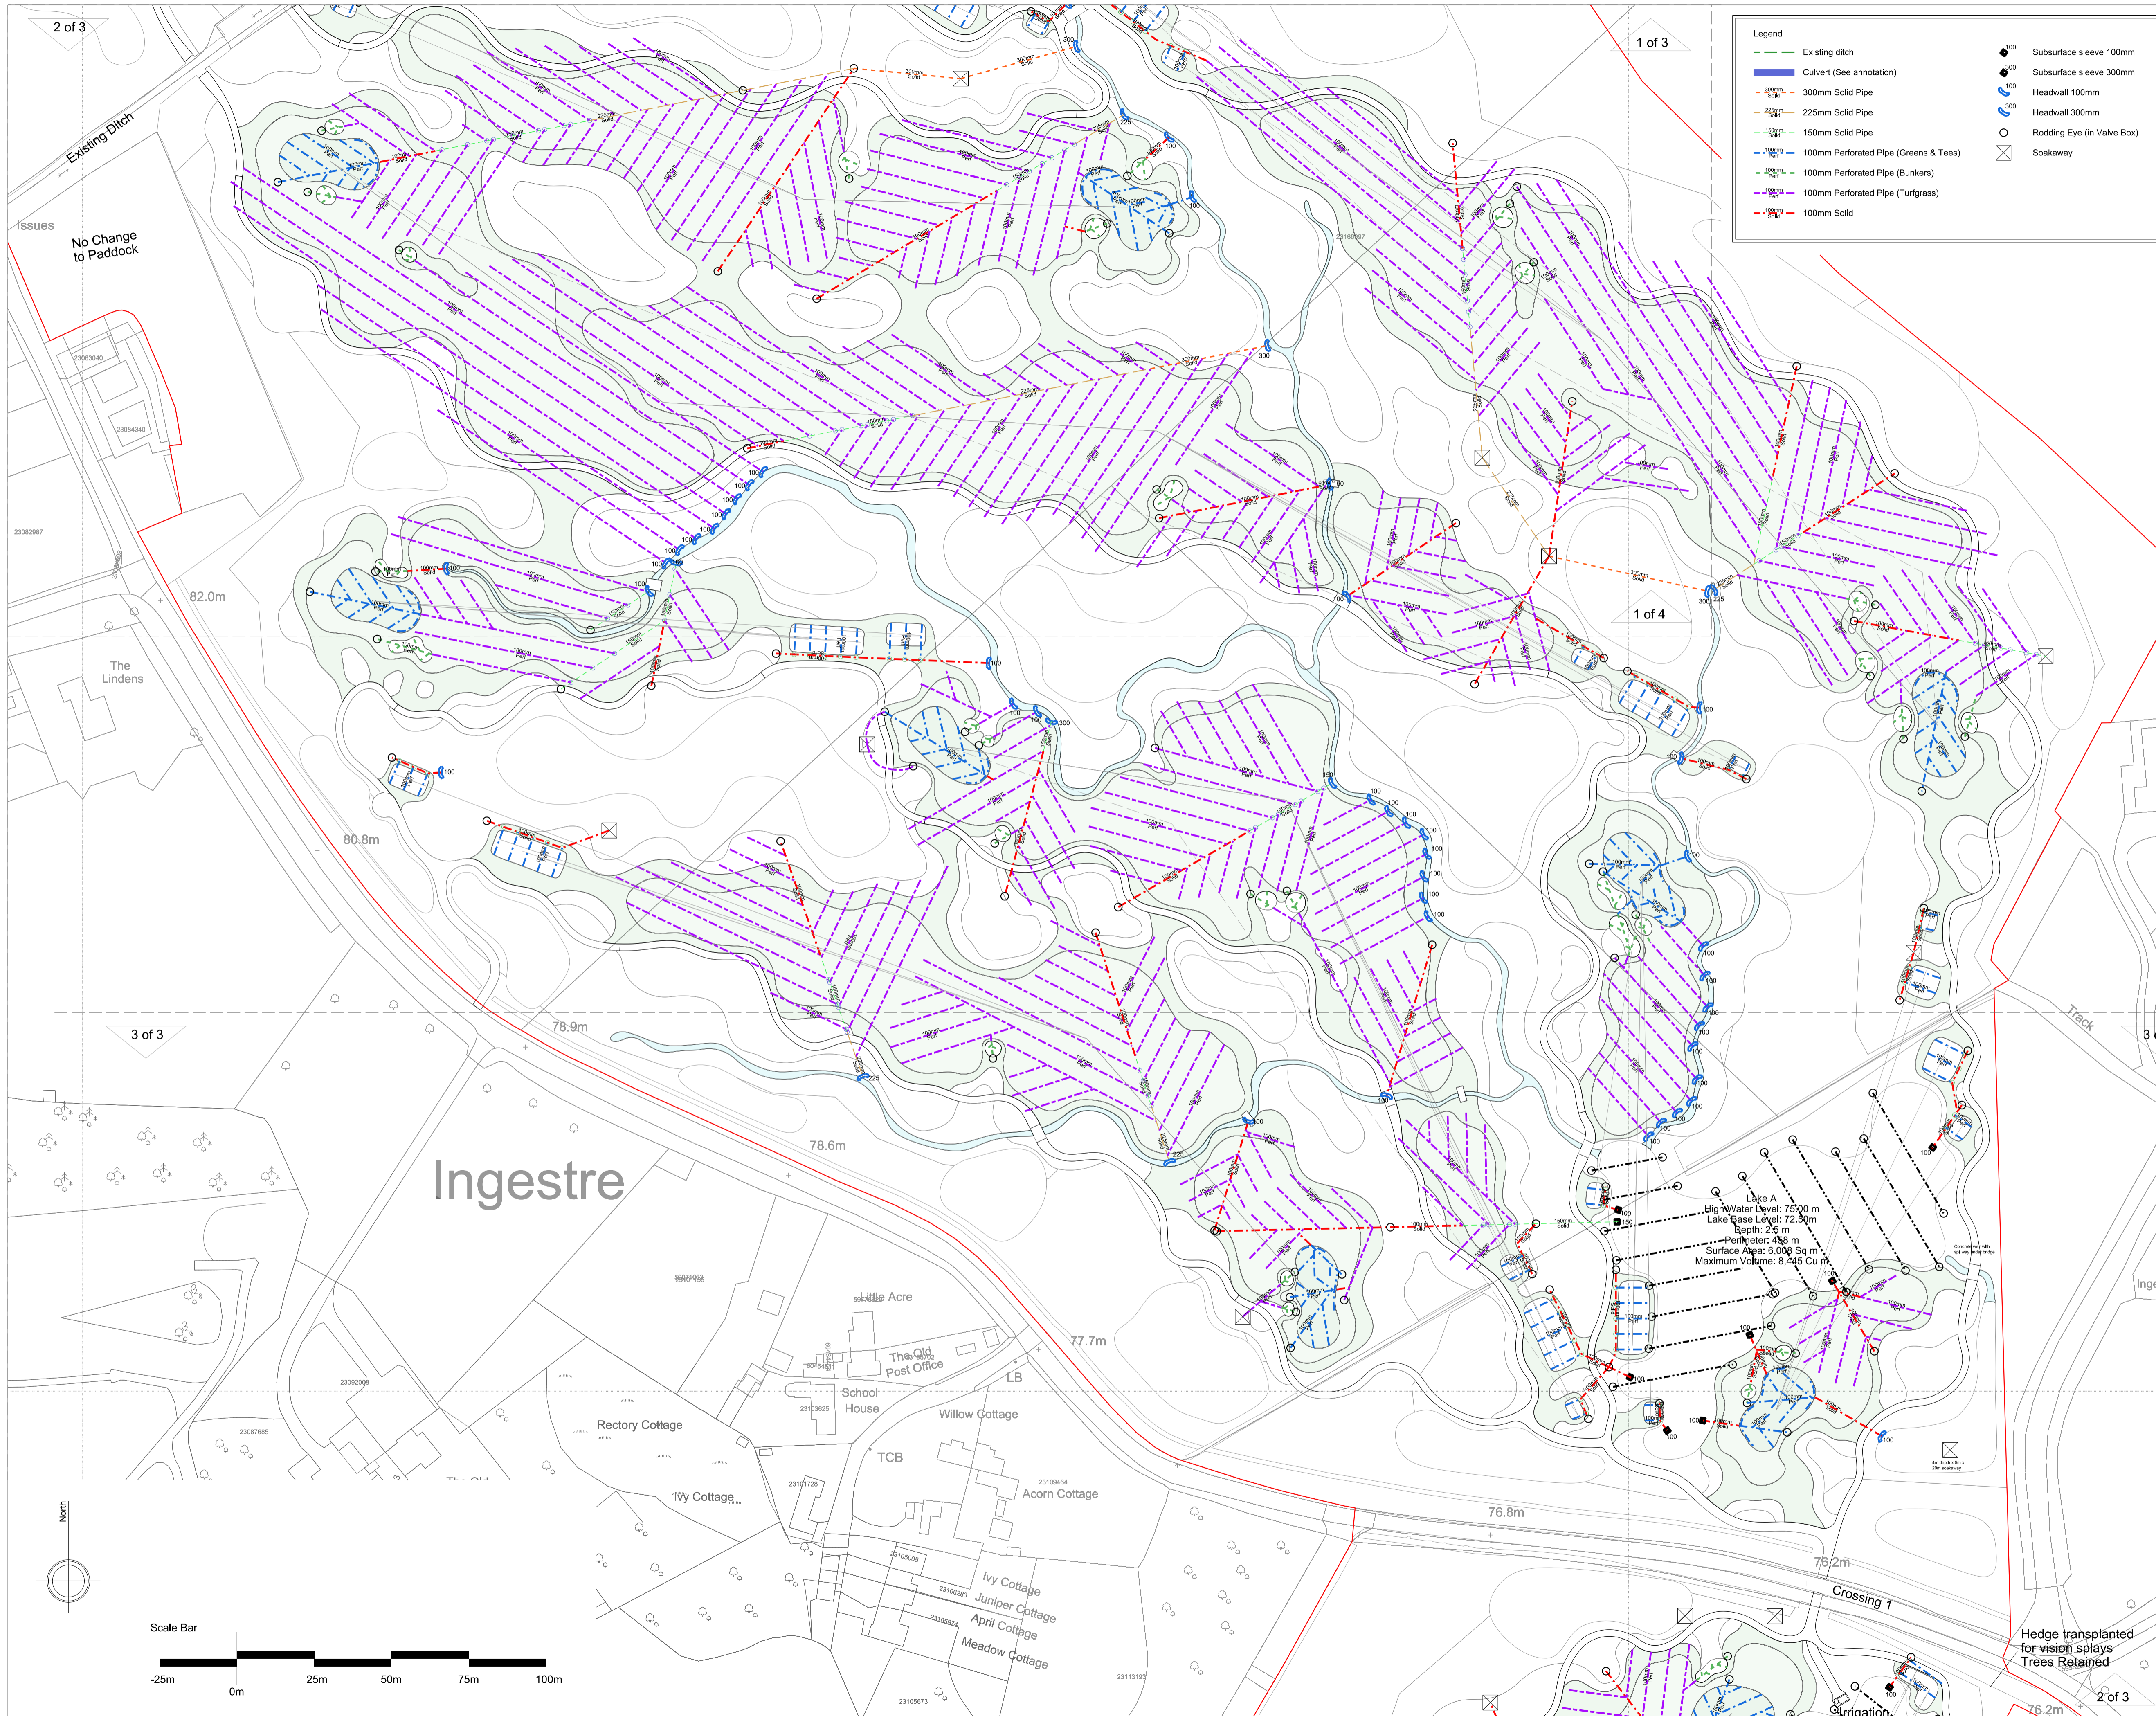


**GENERAL NOTES**

01.

**REVISIONS**

REV	DATE	DESCRIPTION	REV BY	CHK BY

**KEY PLAN**

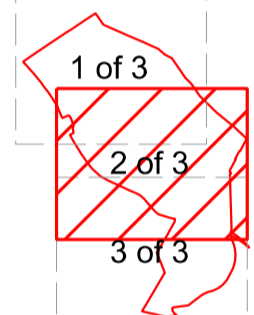

**CONSULTANT**



**LEAD CONSULTANT**

**CLIENT**



**ISSUED FOR**



**PROJECT**

**DRAWING TITLE**


Drainage Plan 2 of 3

Drawn	JH	Checked	AC	Approved	RH
Date	30/07/2020	Sheet Size	A1	Scale	1:1000 @A1
Drawing No.	9882 NC 710-2 PROPOSED GOLF COURSE DRAINAGE PLAN 2 OF 3			Rev.	

CAD File No. 9882 NC 710-2 PROPOSED GOLF COURSE DRAINAGE PLAN 2 OF 3  
 Consultant Project No. 9882 NC 710-2 PROPOSED GOLF COURSE DRAINAGE PLAN 2 OF 3  
 This drawing, the designs and details shown are the copyright of International Design Group and shall not be copied or reproduced in any form without their written consent.

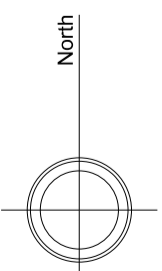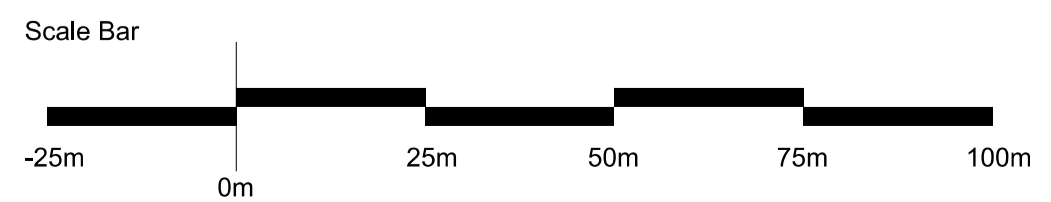



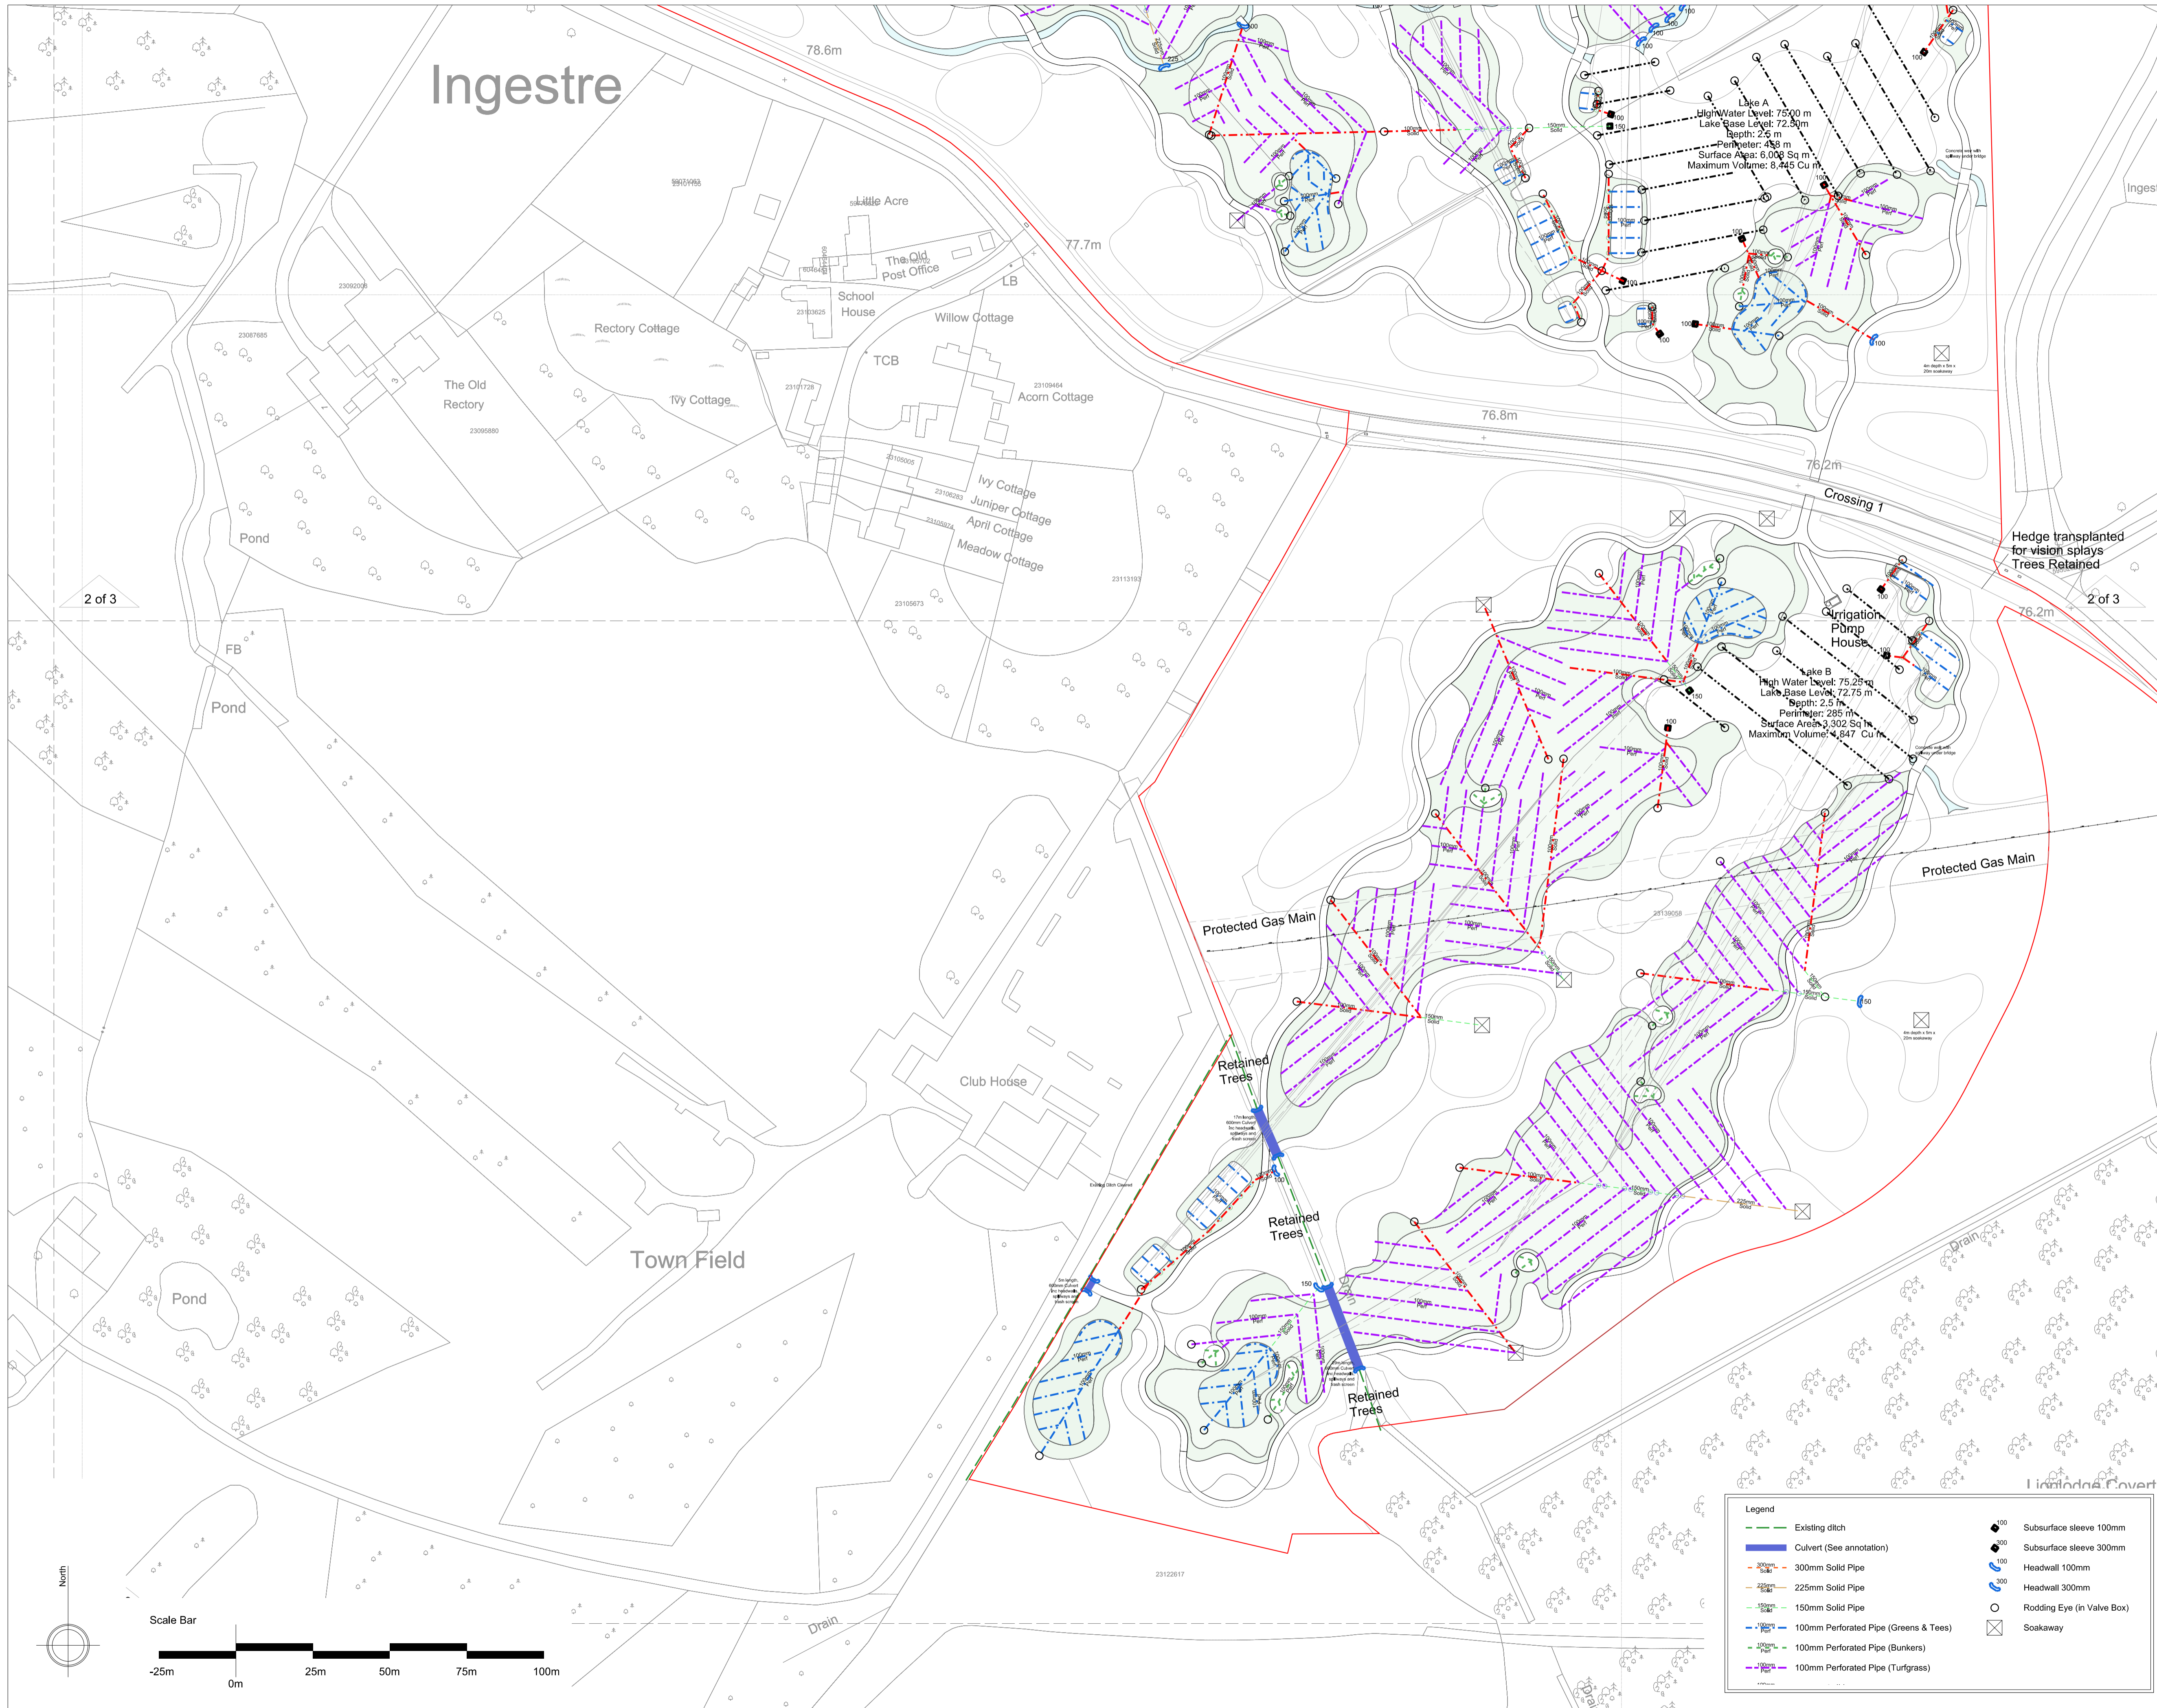


GENERAL NOTES  
01.

REVISIONS

REV	DATE	DESCRIPTION	REV BY	CHK BY

KEY PLAN

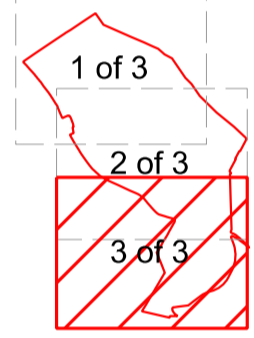

CONSULTANT



LEAD CONSULTANT

CLIENT



ISSUED FOR

PROJECT

DRAWING TITLE

Drainage Plan 3 of 3

Drawn	JH	Checked	AC	Approved	RH
Date	30/07/2020	Sheet Size	A1	Scale	1:1000 @A1
Drawing No.	G982 NC 710-3 PROPOSED GOLF COURSE DRAINAGE PLAN 3 OF 3			Rev.	

CAD File No. G982 NC 710-3 PROPOSED GOLF COURSE DRAINAGE PLAN 3 OF 3  
Consultant Project No. G982 NC 710-3 PROPOSED GOLF COURSE DRAINAGE PLAN 3 OF 3

This drawing, the designs and details shown are the copyright of International Design Group and shall not be copied or reproduced in any form without their written consent.

© INTERNATIONAL DESIGN GROUP

Legend	
	Existing ditch
	Culvert (See annotation)
	300mm Solid Pipe
	225mm Solid Pipe
	150mm Solid Pipe
	100mm Perforated Pipe (Greens & Tees)
	100mm Perforated Pipe (Bunkers)
	100mm Perforated Pipe (Turfgrass)
	Subsurface sleeve 100mm
	Subsurface sleeve 300mm
	Headwall 100mm
	Headwall 300mm
	Rodding Eye (in Valve Box)
	Soakaway





Legend	
	Green (5701 Sq M)
	Tee (3613 Sq M)
	Green Approaches (2869 Sq M)
	Lakes (9310 Sq M)

GENERAL NOTES				
01.				
02.				
03.				
04.				
05.				

REVISIONS				
REV	DATE	DESCRIPTION	REV BY	CHK BY

KEY PLAN

CONSULTANT



LEAD CONSULTANT

CLIENT



ISSUED FOR  
Planning Direction

PROJECT  
Ingestre Park Golf Club

DRAWING TITLE  
Irrigated Areas Plan

Drawn	JH	Checked	AC	Approved	RH	
Date	21/07/2020	Sheet Size	A1	Scale	1:2500 @A1	
Drawing No.	G982 NC 713 IRRIGATION SCHEME				Rev.	--

CAD File No. G982 NC 713 IRRIGATION SCHEME  
Consultant Project No.

This drawing, the designs and details shown are the copyright of International Design Group and shall not be copied or reproduced in any form without their written consent.  
© INTERNATIONAL DESIGN GROUP