


FIRE ALARMS AFD system to BS 5839 Part 1, Category L1/M smoke detector system is to be installed, which has automatic detectors installed throughout all areas of the building (including roof spaces and voids) with the aim of providing the earliest possible warning. In practice, detectors should be placed in nearly all spaces and voids. With category 1 systems, the whole of a building is covered apart from minor exceptions.

KEY:
 Existing
 Proposed
 Demolished

Notes:
 Confirm all dimensions on site prior to any off site manufacturing.
 At construction phase do not scale from drawing, use figured dimensions only.
 Dimensions are in millimetres and to structure unless stated otherwise.
 Report any discrepancies, conflicts or errors to architect prior to proceeding.
 Refer to structural engineers design for all load bearing elements, bracing, movement joints and below ground drainage.
 Refer to mechanical and electrical engineers design for all building services.
 All works to comply with relevant British Standards and Building Regulations.
 This drawing and design is the property of 3bd LLP and is issued under license to the named recipient only. All copyright law protecting design, artistic & literary work contained within this drawing remains.

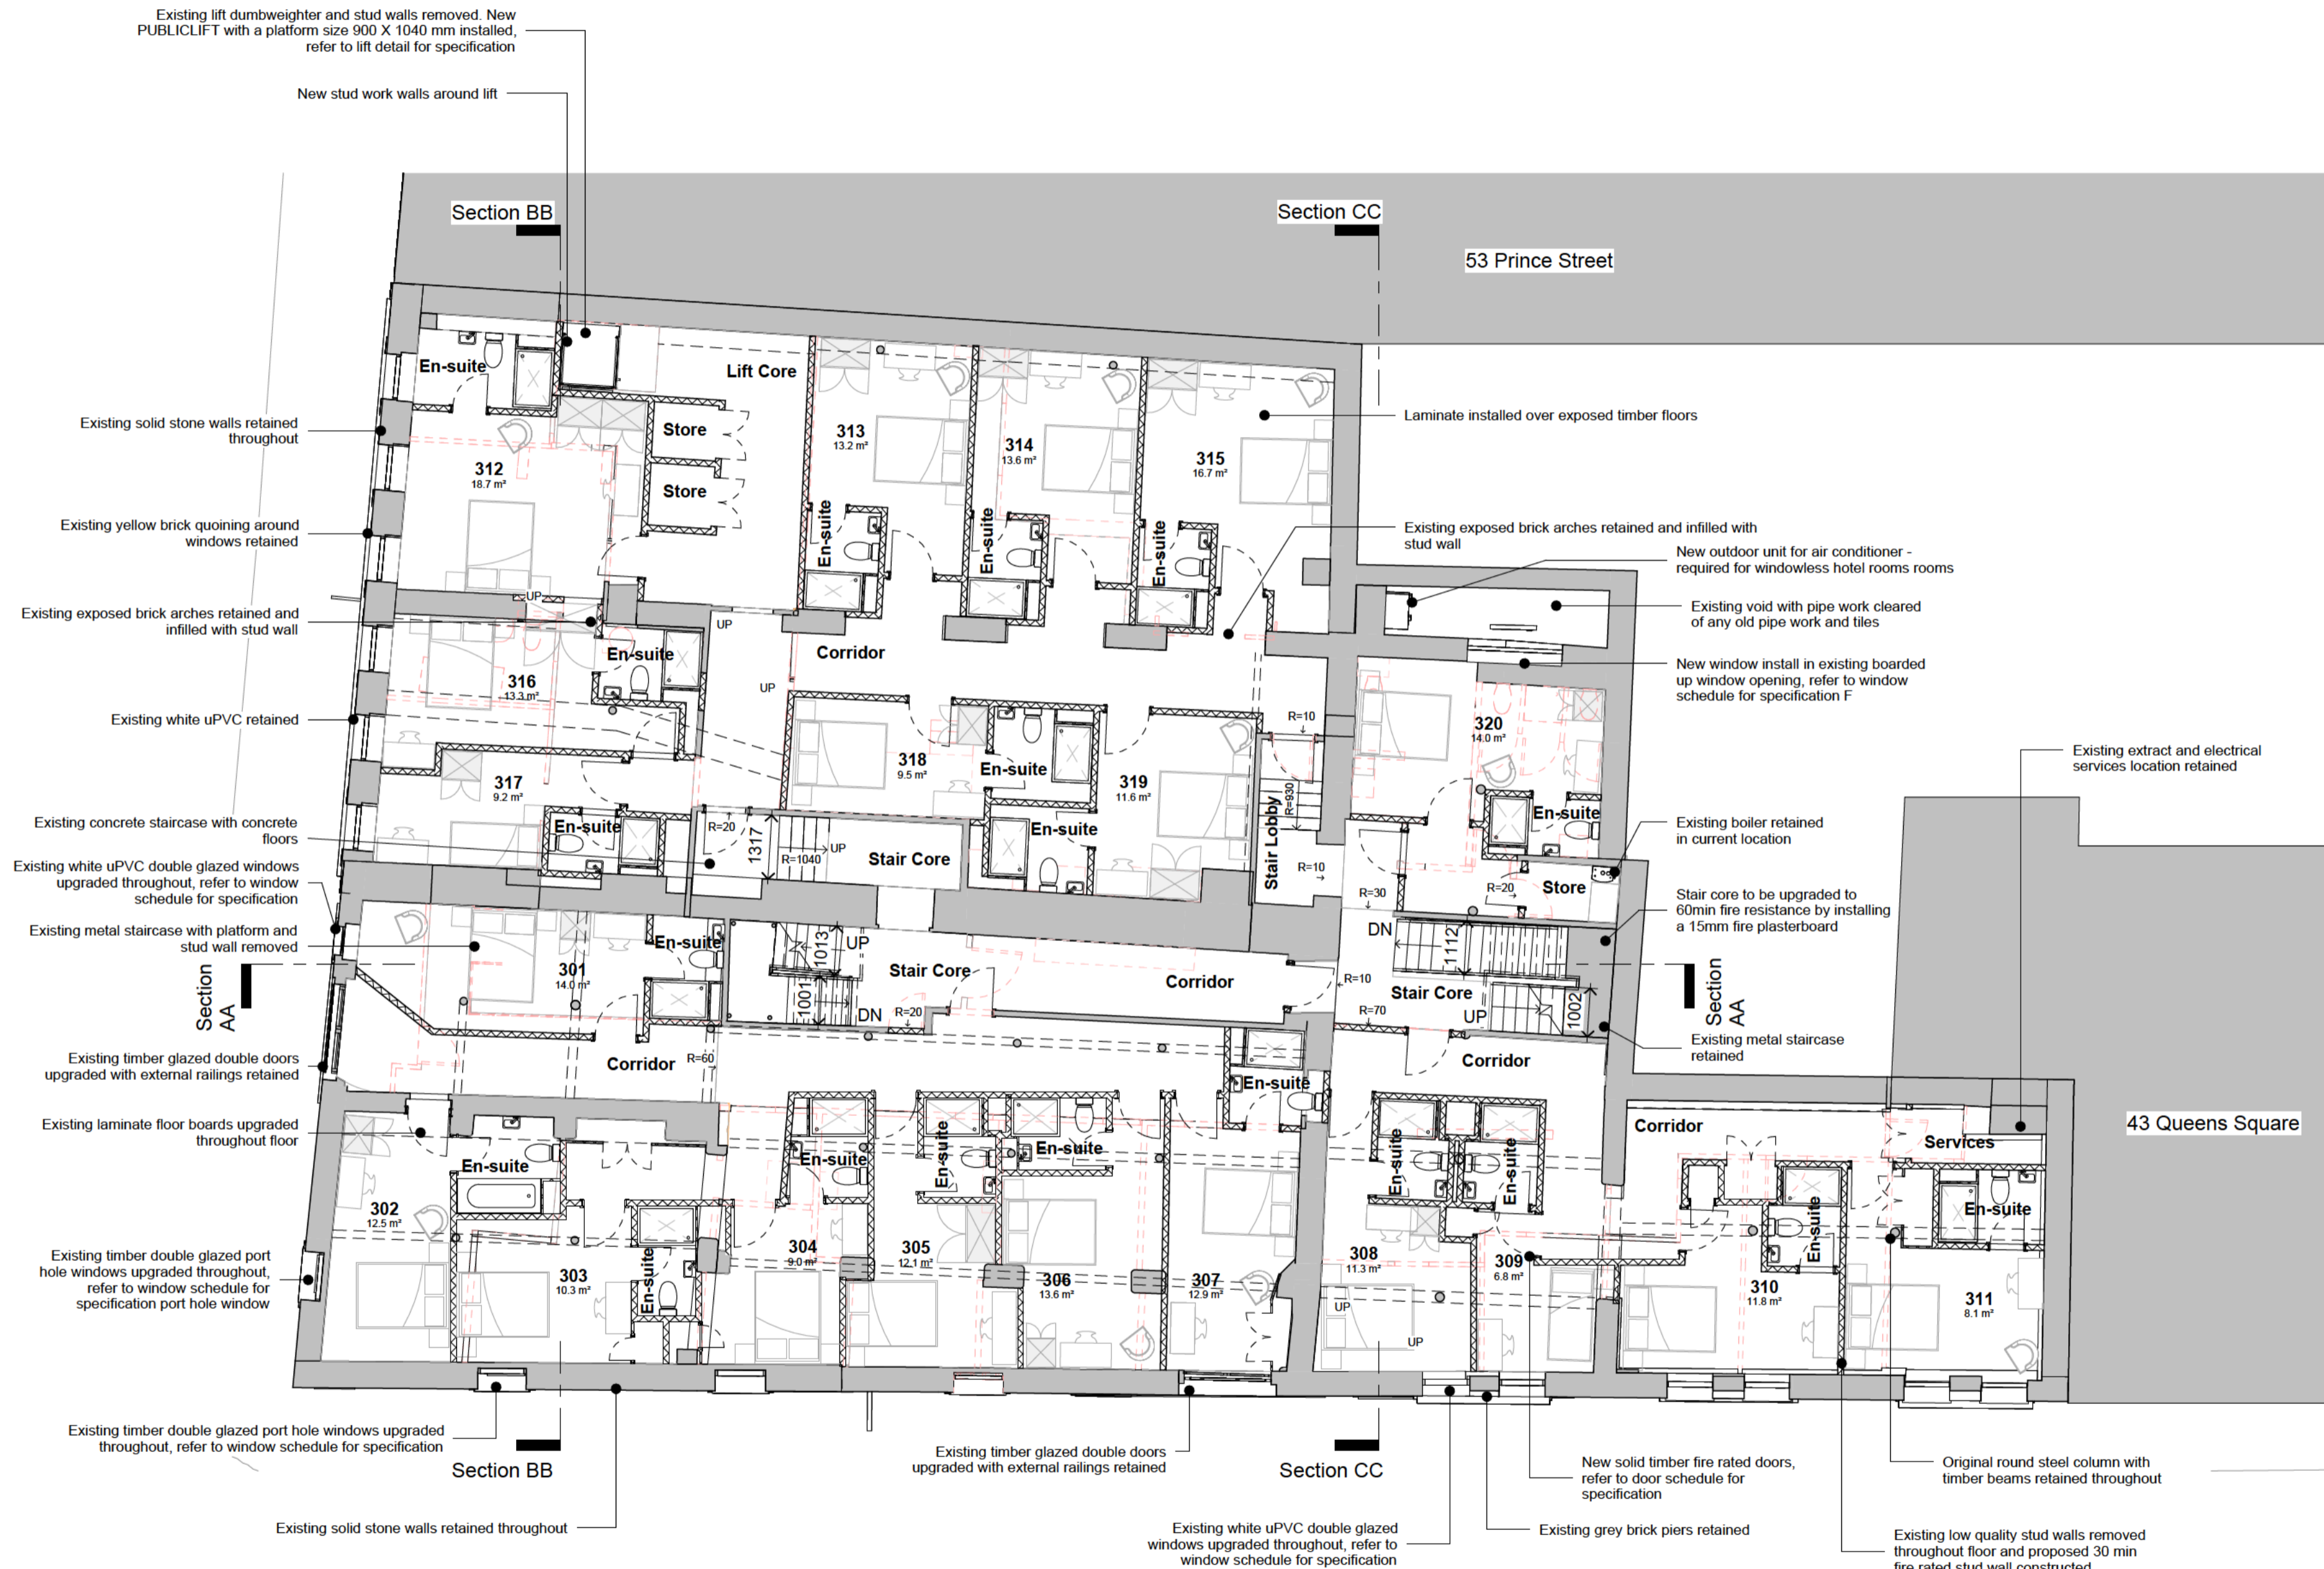

C	Updated to comments	04/03/24
B	Issued to the client	31/01/24
Rev	Description	Date

FOR PLANNING

3bd LLP
 Architects
 RIBA Chartered Practice © 2021
 15&17 Backfields Lane, Stokes Croft, Bristol, BS2 8QW
 T 01173 707 380 e.partners@3bdarchitects.com

Client	Vijay Patel
Project	57 Prince Street, Bristol BS1 4QH
Drawing Title	PROPOSED THIRD FLOOR PLAN
Drawing Number	388-PLA- 113
Date	Jan '24
Scale	1 : 100@ A2
Drawn	JB
Chkd	SR

