


- Existing tree to be retained
- Tree to be removed
- Proposed tree
- Proposed new boundary yew hedge
- Proposed new boundary - 1.5m post and rail fence
- Proposed new boundary - 1.8m close boarded fence
- Green areas laid to lawn
- Rear garden patios, laid to fall away from dwellings
- Permeable gravel driveways
- Tarmac Road
- Filtration strip - With kerb gap system
- Surface water drain run - 150mm dia. pipe unless stated otherwise on plan

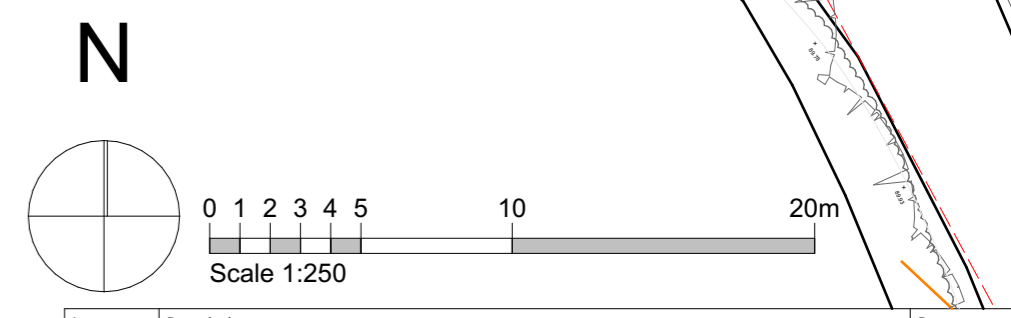

Issue	Description	Date
A	Amendments to Drainage Layout	23/04/2024

Pelham Structures
LIMITED

Unit 3, Birches Yard, Butts Green, Clavering, Essex CB11 4RT,
Tel: 01799 551201, Fax: 01799 551204, Email: info@pelhamstructures.co.uk

Project name: Land East of Ugley Village Hall, Ugley		
Drawing title: Site Drainage Layout		
Scale: 1:250	Date: 07/05/2024	Drawing no: 596 x PL19 A
Paper: A1 Paper	Drawn: SJT	

All dimensions are in millimeters unless otherwise stated. Do not scale from this drawing. If in doubt, ask.